


A1




Convocation Center Level 1 Floor Plan

| DWN | DATE |
|------|-----------|
| STK | 3-27-2014 |
| REV. | DATE |
| | |
| | |
| | |

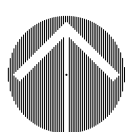

SCALE: 1/32" = 1'-0"

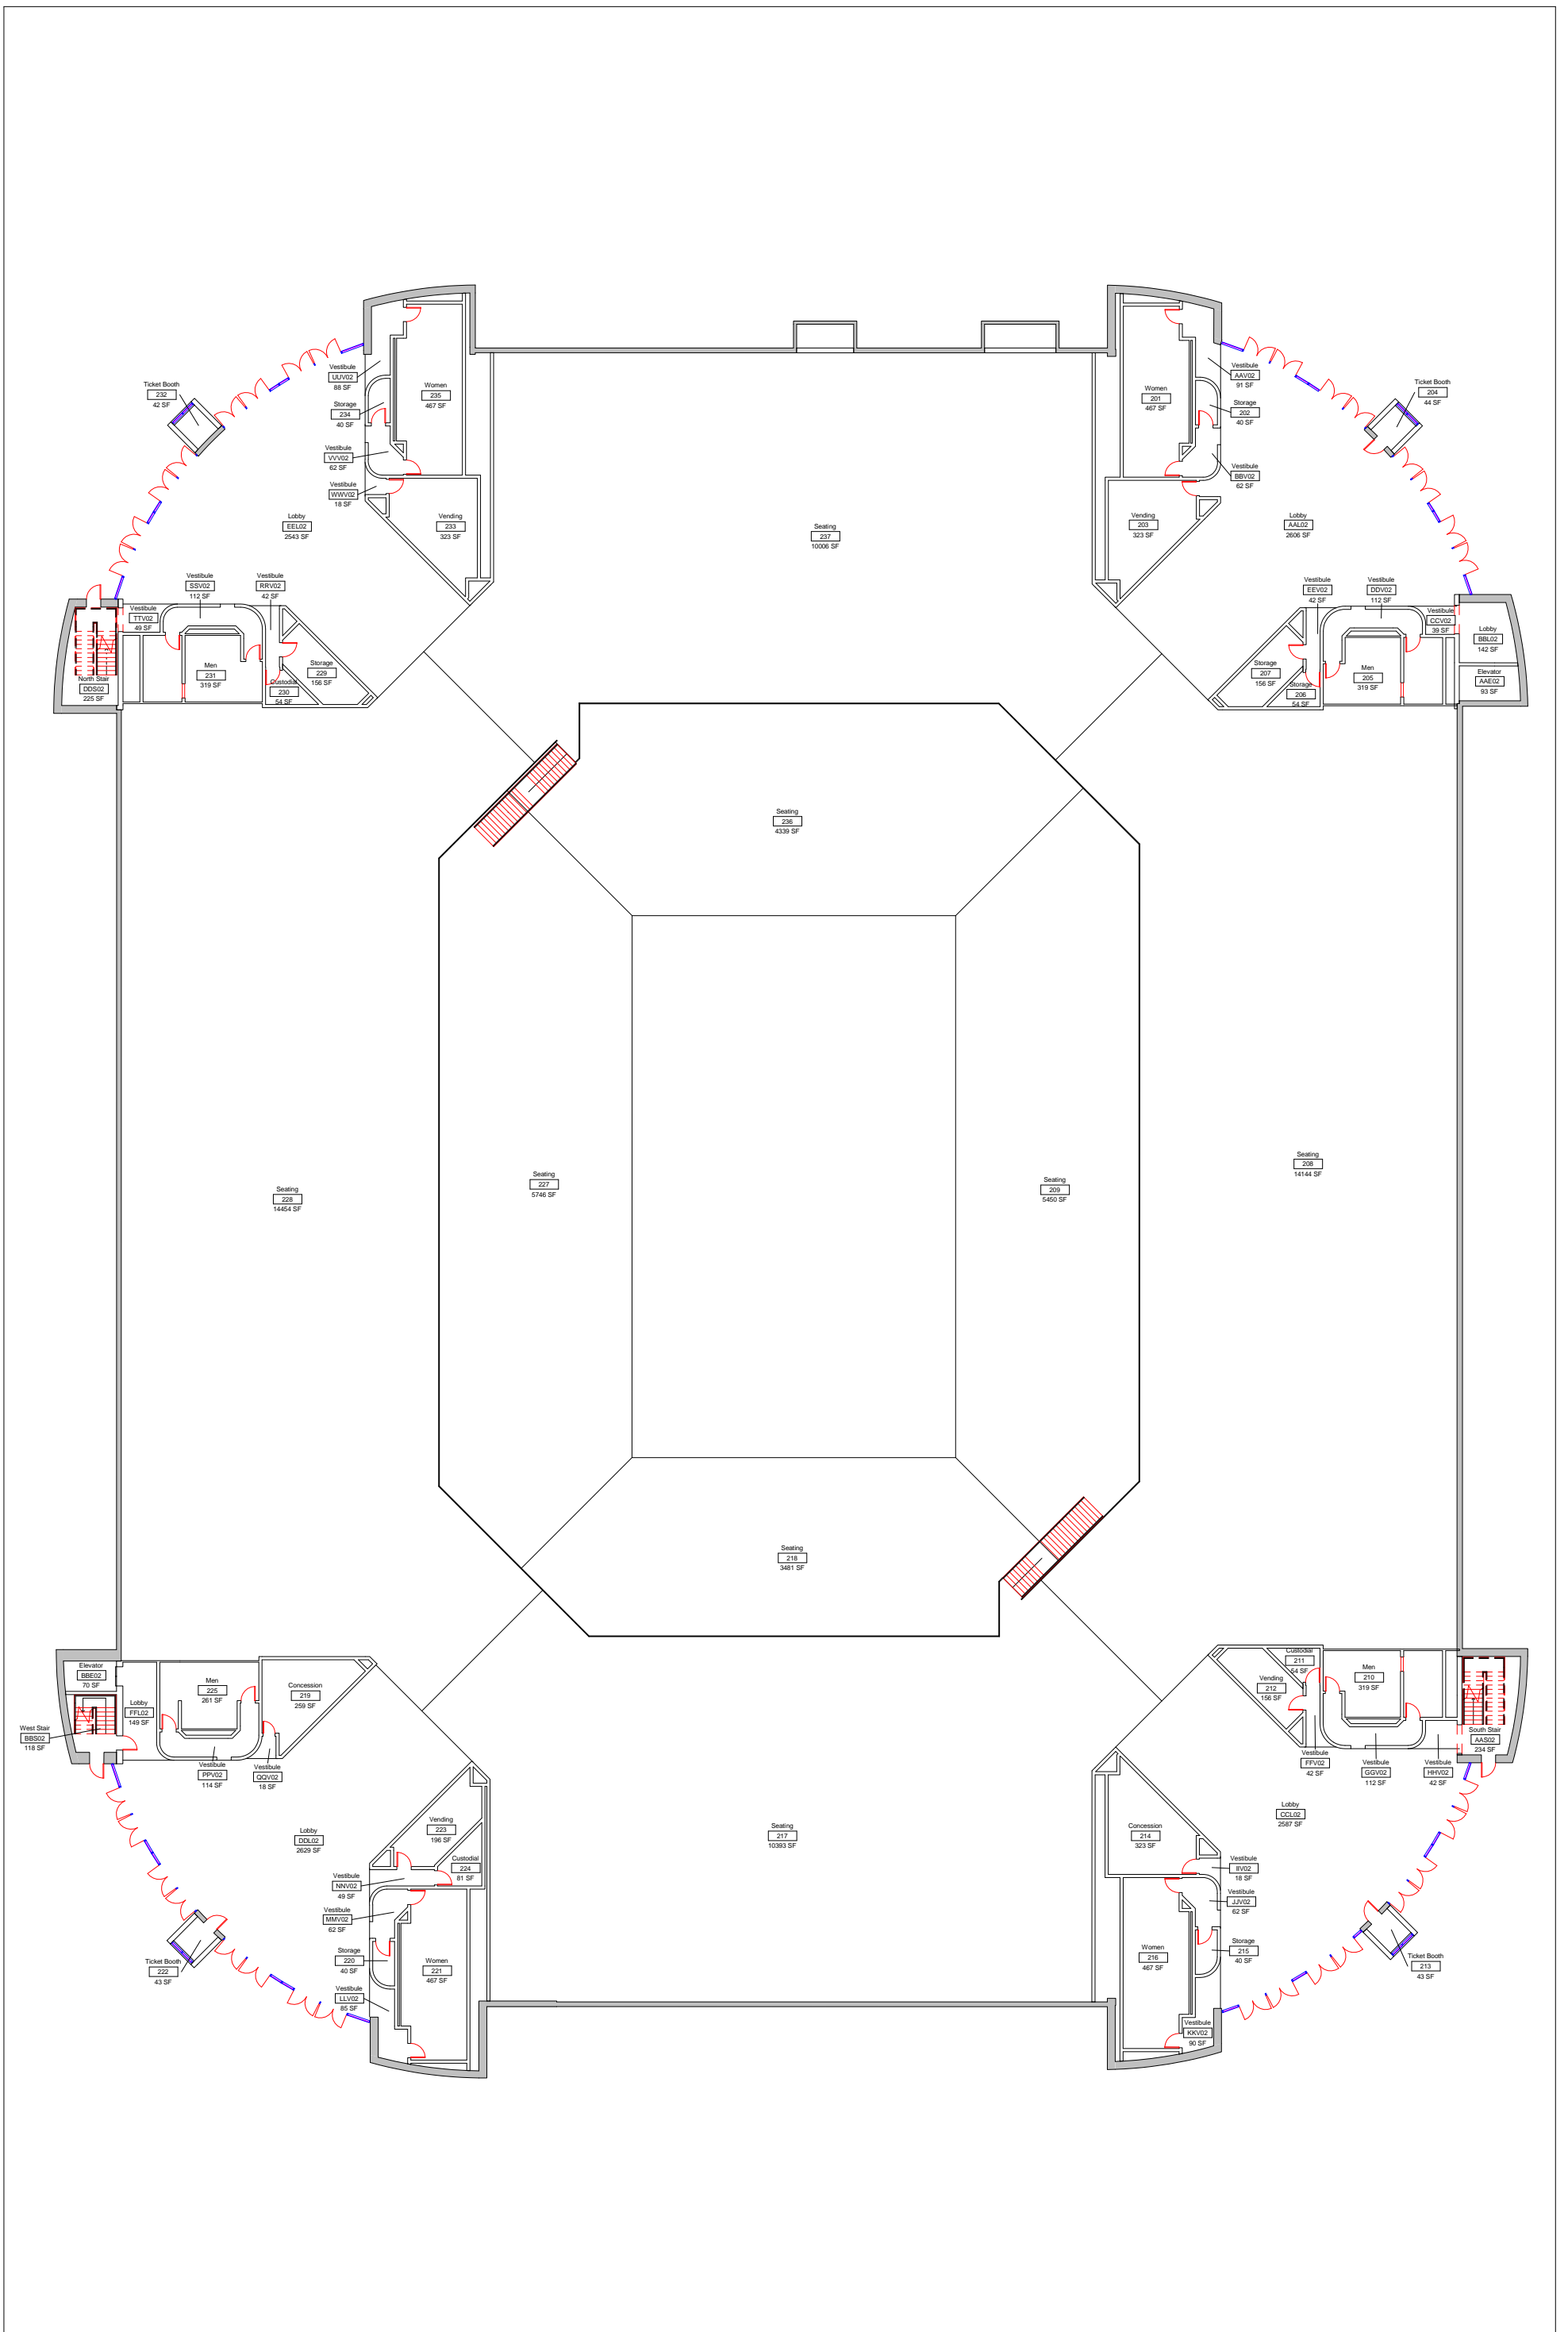

A2







Convocation Center
Level 2 Floor Plan

| DWN | DATE |
|------|-----------|
| STK | 3-27-2014 |
| REV. | DATE |
| | |
| | |
| | |
| | |



SCALE: 1/32" = 1'-0"

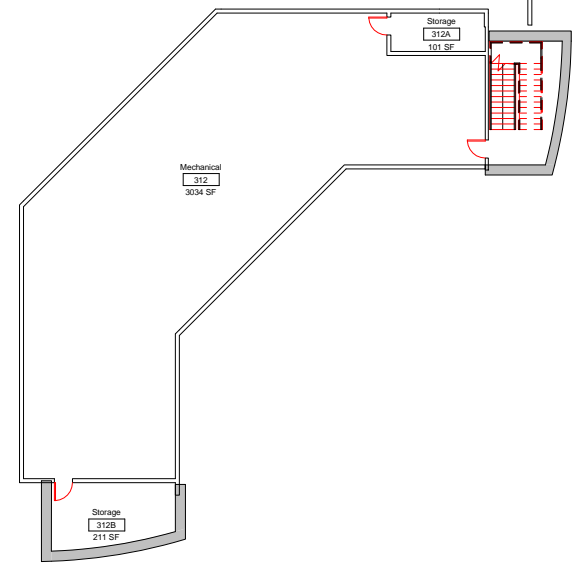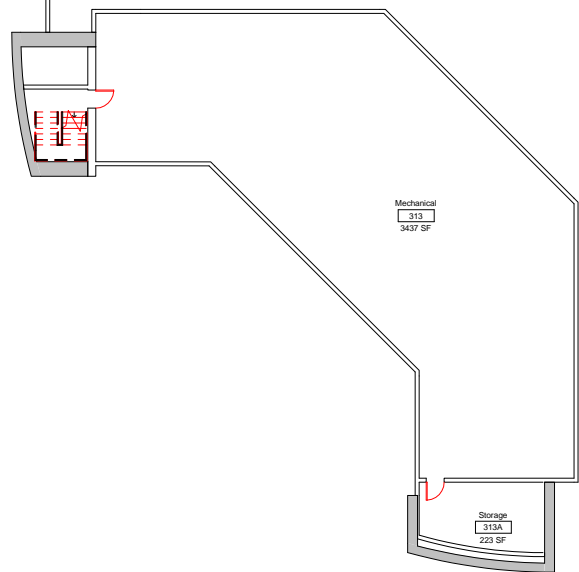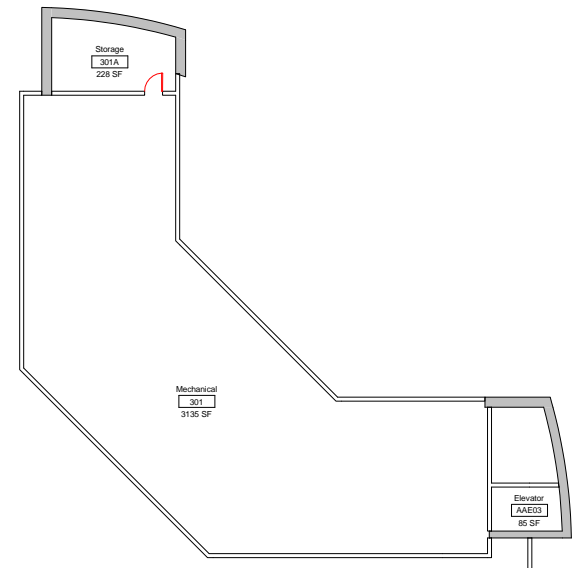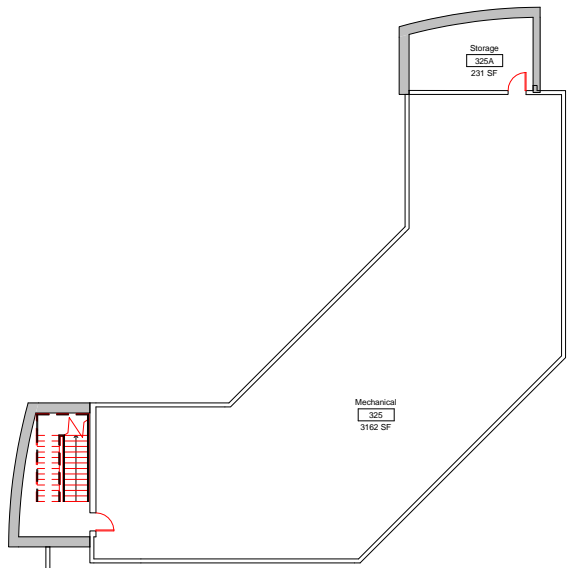

A3





Convocation Center
Level 3 Mechanical Floor Plan

| DWN | DATE |
|------|-----------|
| STK | 3-27-2014 |
| REV. | DATE |
| | |
| | |
| | |
| | |



SCALE: 1/32" = 1'-0"

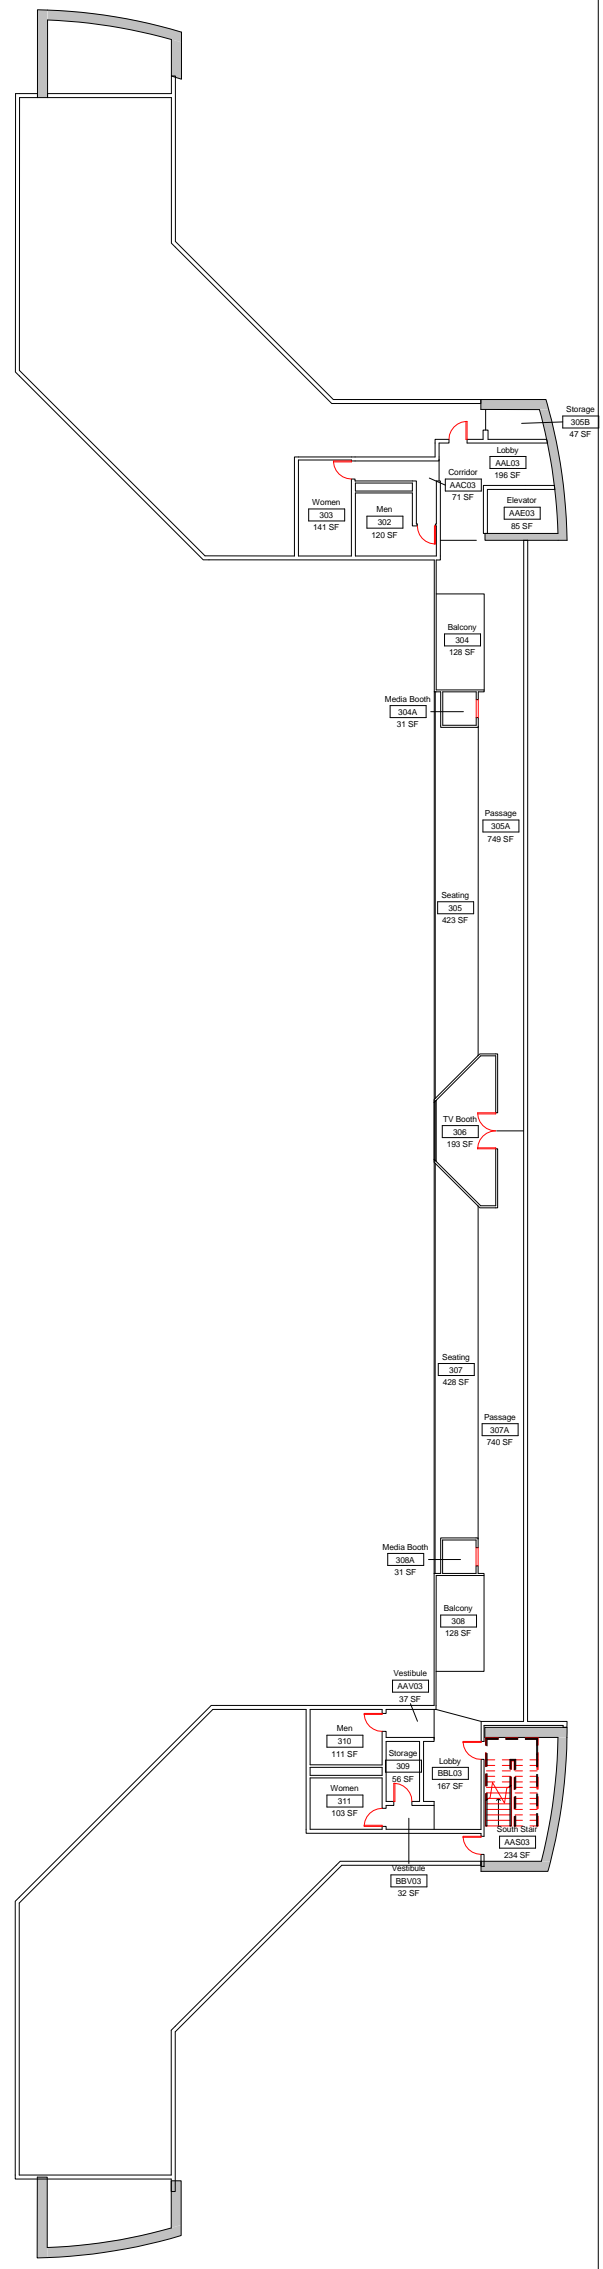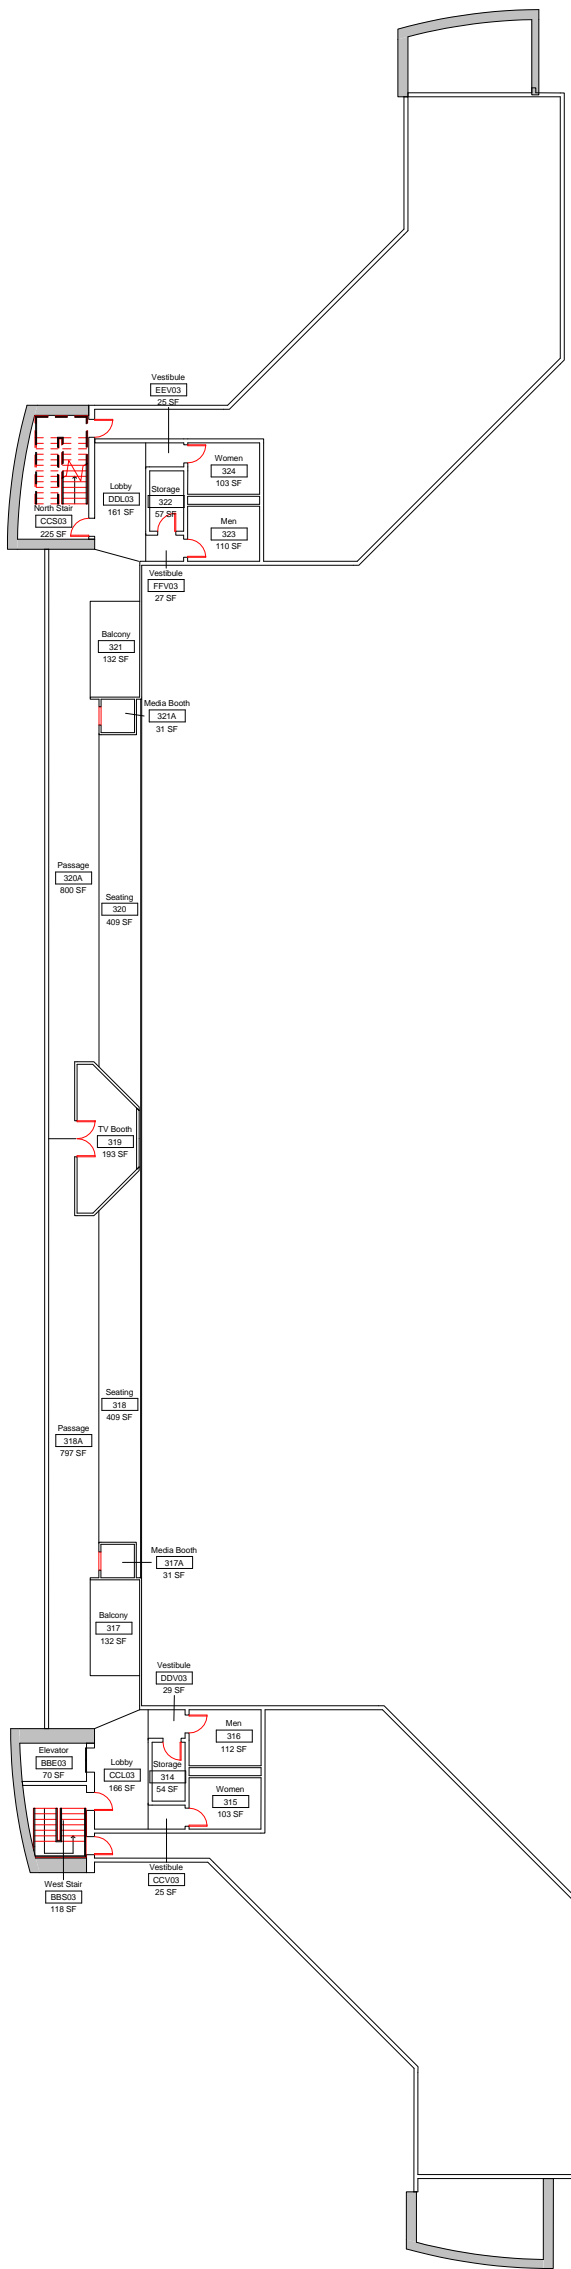

A4



Convocation Center
Level 3 Seating Floor Plan

| DWN | DATE |
|------|-----------|
| STK | 3-27-2014 |
| REV. | DATE |
| | |
| | |
| | |
| | |



SCALE: 1/32" = 1'-0"